


**GENERAL NOTES**

1. THE POSITION OF A/C MACHINE COULD BE CHANGED UPON REQUEST OF A/C DESIGNER. SOMETIME THE OPENING FOR DUCTS, REFRIGERANT PIPES COULD BE RELOCATED AND ALSO SIZE OF OPENINGS COULD BE CHANGED.
2. ALL CONTRACT DRAWINGS HAS TO BE SIGNED BY THE OWNER DRAWING FOUND WITHOUT THE SIGNATURE OF THE OWNER WILL NOT BE CONSIDERED AS CONTRACT DRAWINGS.
3. ALL DIMENSION ARE IN MILLIMETERS UNLESS OTHER WISE SPECIFIED.

سند  
 — SEWER PIPE LINE  
 — WATER PIPE LINE

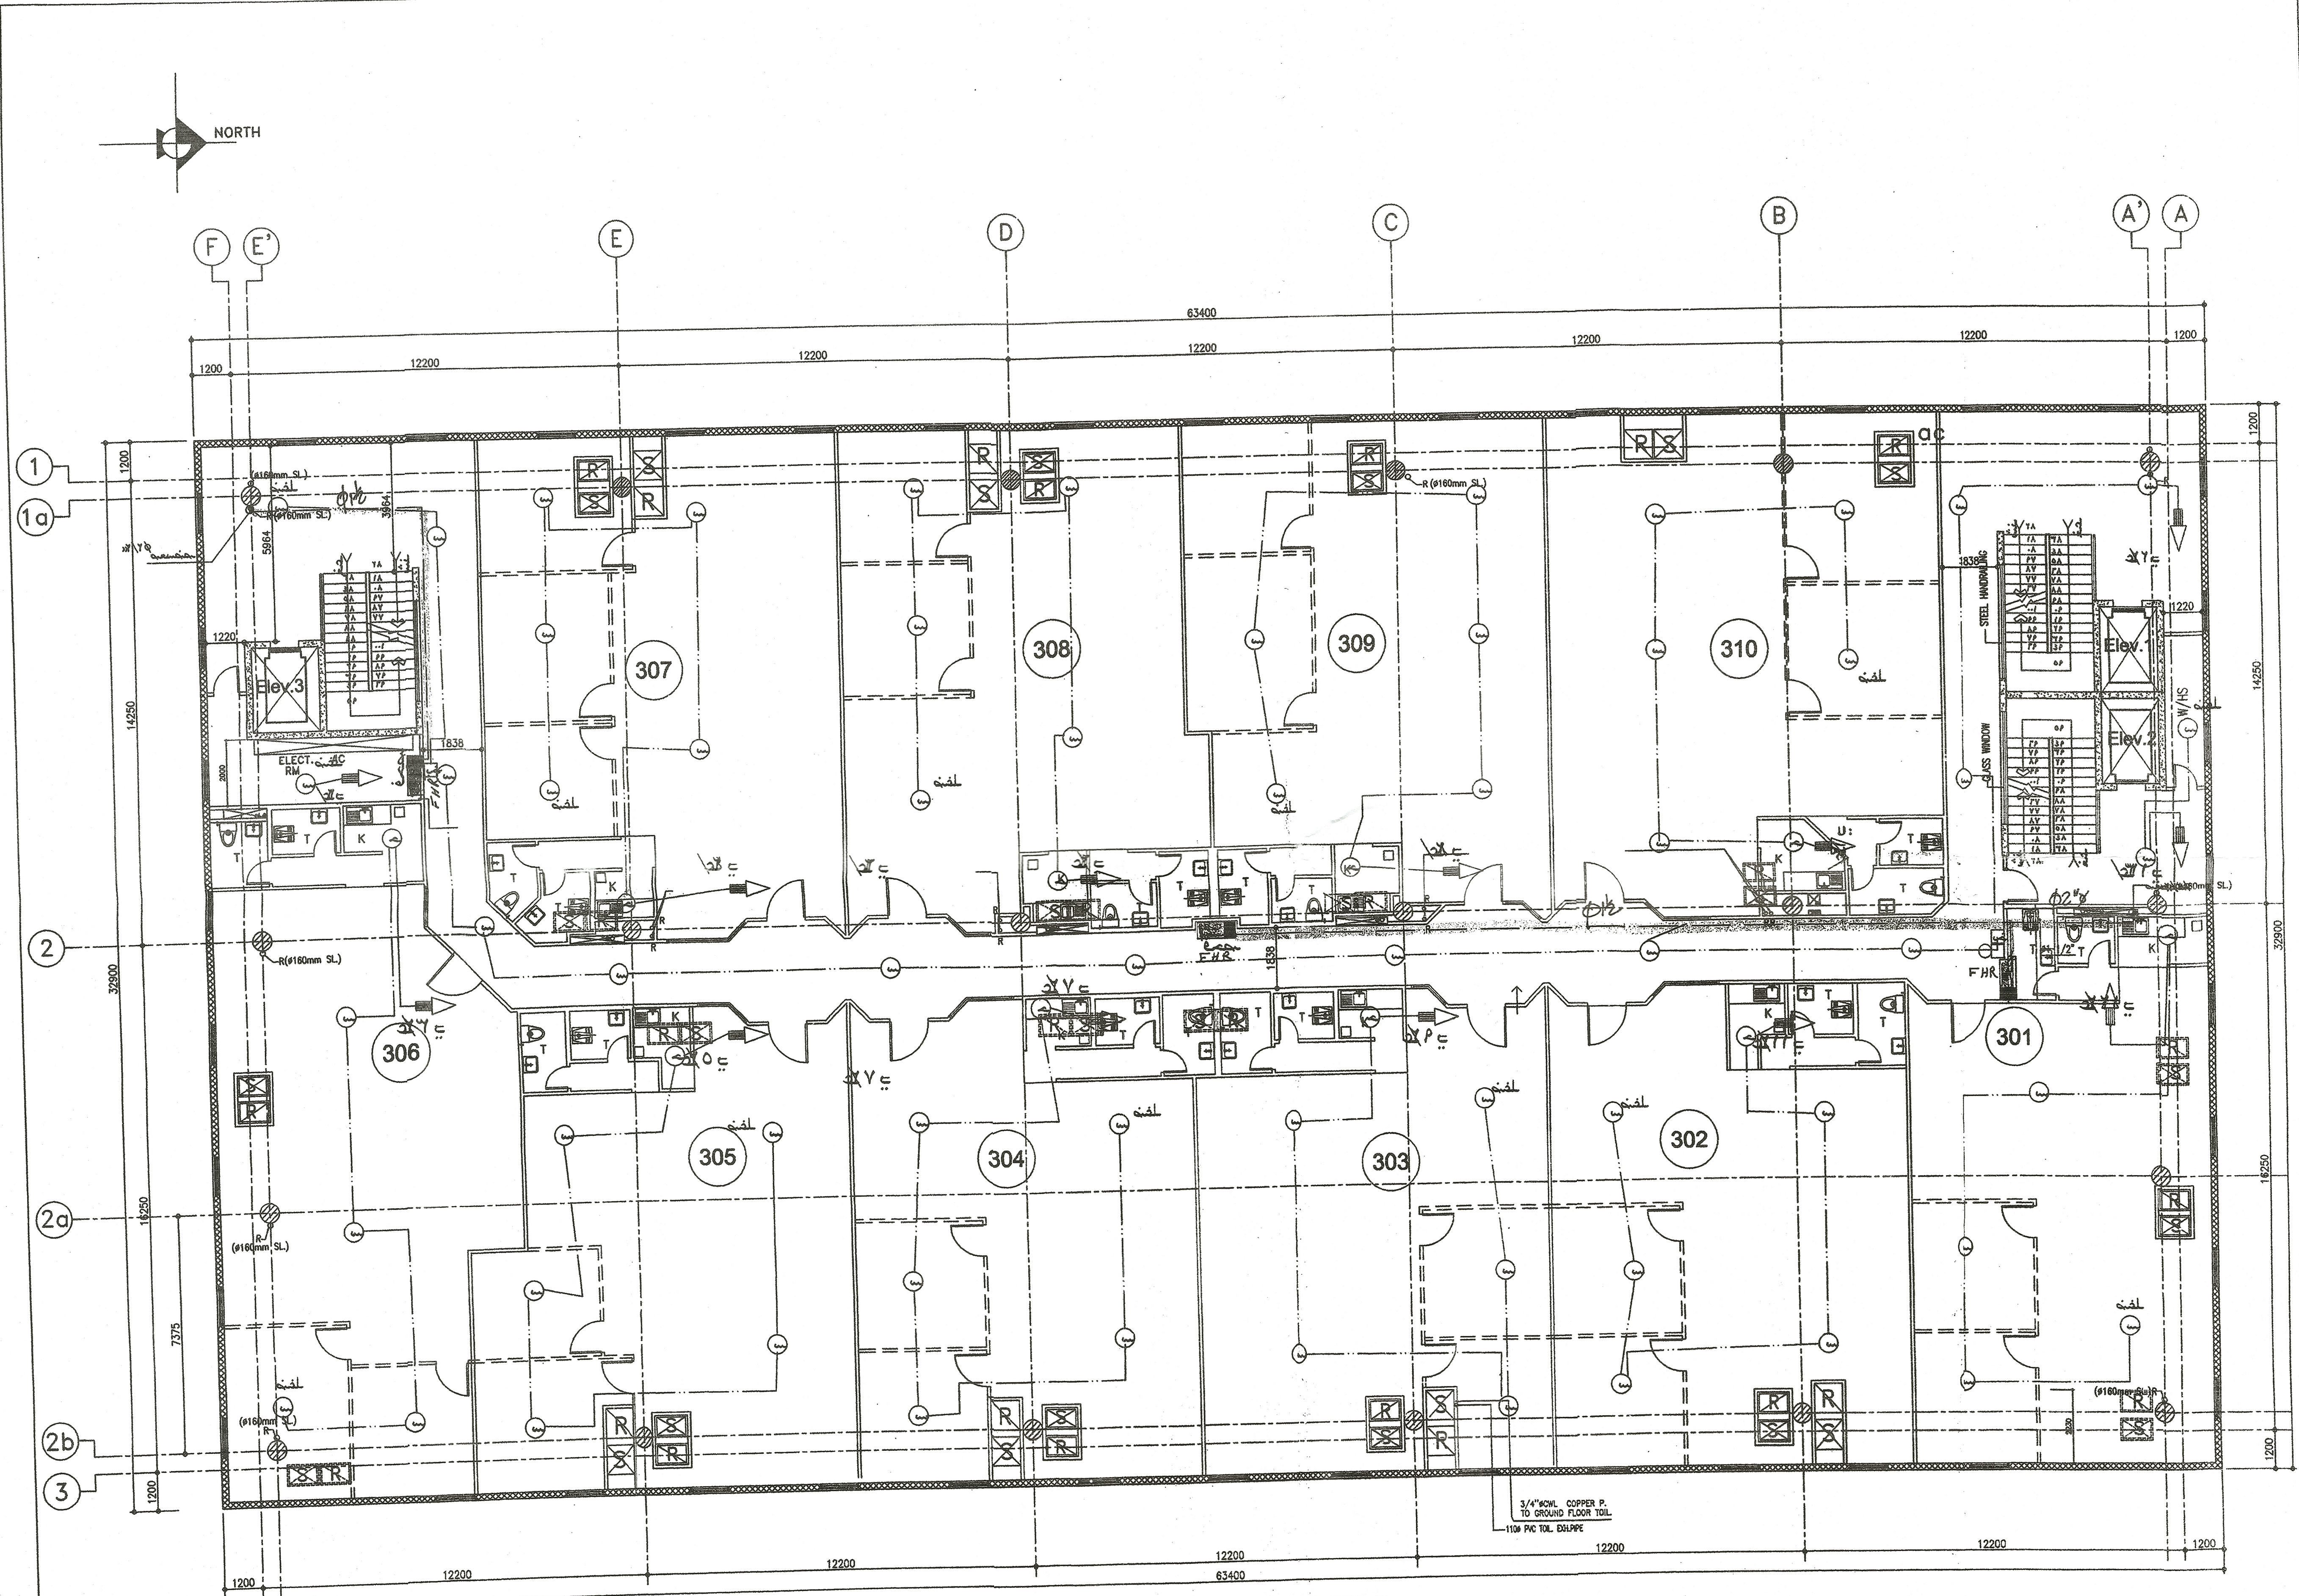

**PIPE LEGEND**  
 — PIPE CEILING LEVEL  
 - - - PIPE UNDER SLAB

**SECURITY SYSTEM**  
 FOR ZONE 1 TO 13 /P2  
**FIRE ALARM & FIREFIGHTING SYSTEM**  
**BLDG-W 3RD FLOOR PLAN**



PROJECT NO.	09-09-001
PROJECT NAME	JARIR SHOPPING CENTER IN AL-KHOBAR
DATE	09-09-001
SCALE	1:100
DRAWN BY	
CHECKED BY	
DATE	